


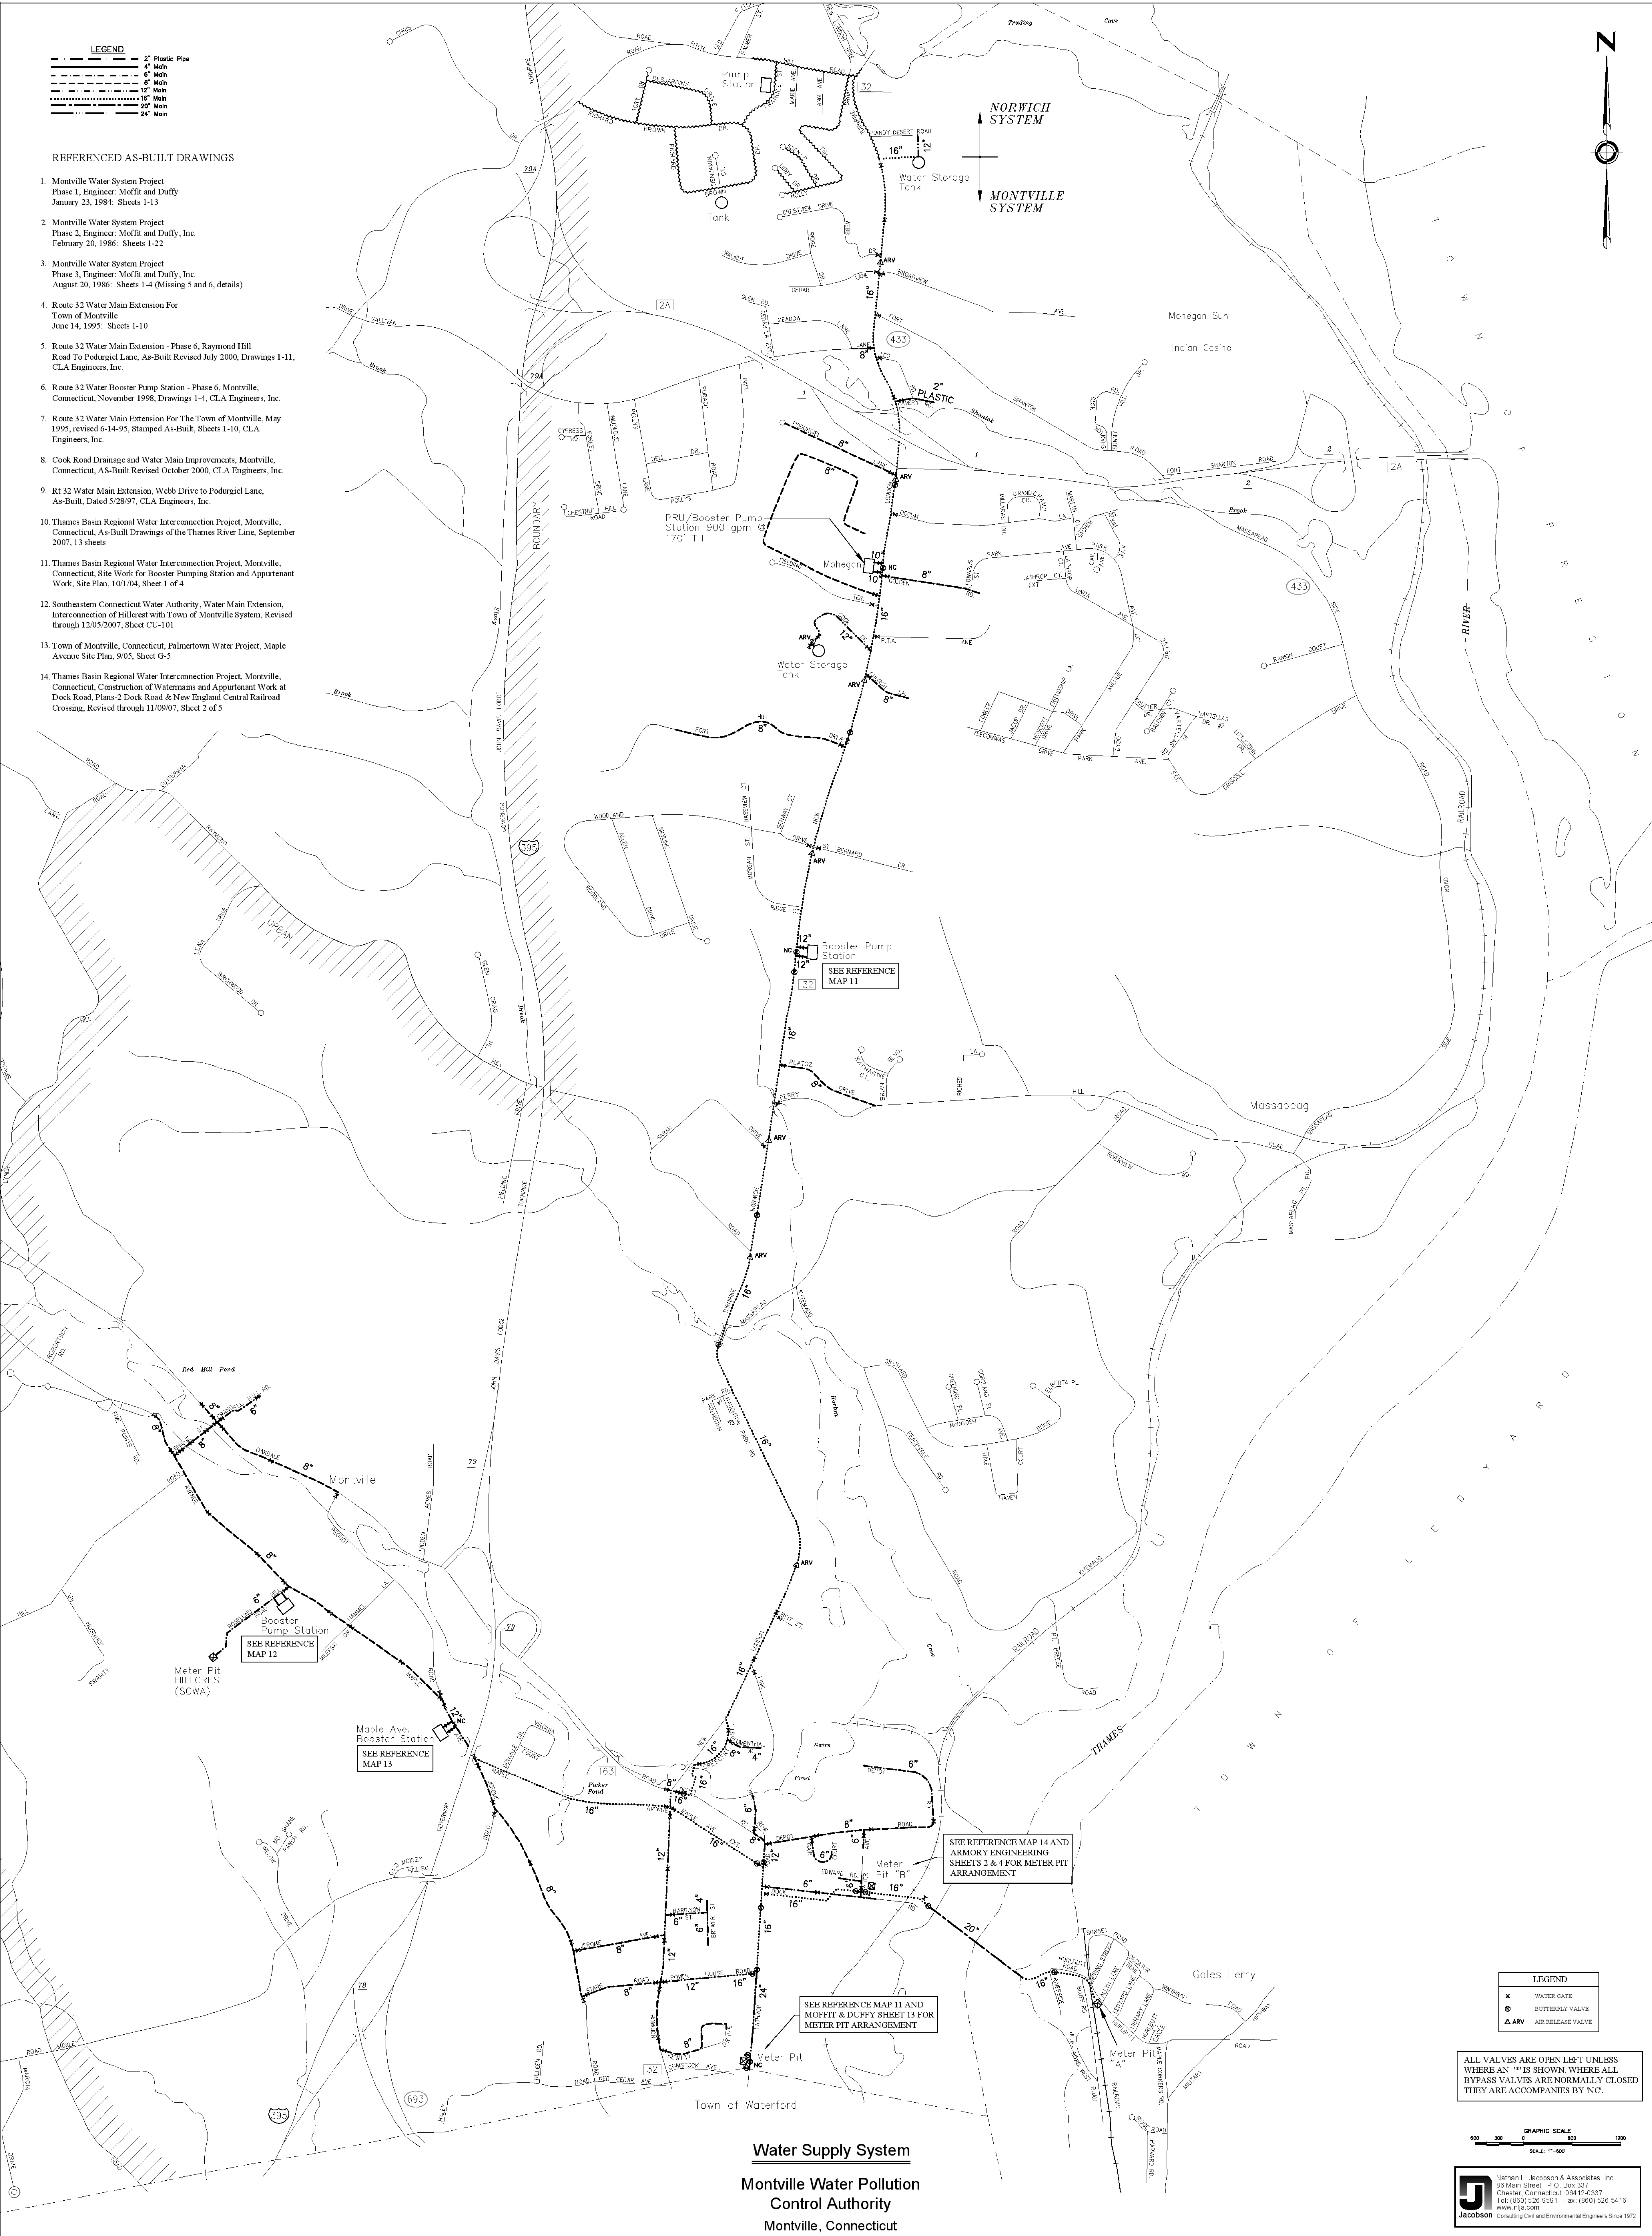

LEGEND

- 2" Plastic Pipe
- 4" Mdn
- 6" Mdn
- 8" Mdn
- 12" Mdn
- 16" Mdn
- 20" Mdn
- 24" Mdn

REFERENCED AS-BUILT DRAWINGS

1. Montville Water System Project
Phase 1, Engineer: Moffit and Duffy
January 23, 1984: Sheets 1-13
2. Montville Water System Project
Phase 2, Engineer: Moffit and Duffy, Inc.
February 20, 1986: Sheets 1-22
3. Montville Water System Project
Phase 3, Engineer: Moffit and Duffy, Inc.
August 20, 1986: Sheets 1-4 (Missing 5 and 6, details)
4. Route 32 Water Main Extension For
Town of Montville
June 14, 1995: Sheets 1-10
5. Route 32 Water Main Extension - Phase 6, Raymond Hill
Road To Podargel Lane, As-Built Revised July 2000, Drawings 1-11,
CLA Engineers, Inc.
6. Route 32 Water Booster Pump Station - Phase 6, Montville,
Connecticut, November 1998, Drawings 1-4, CLA Engineers, Inc.
7. Route 32 Water Main Extension For The Town of Montville, May
1995, revised 6-14-95, Stamped As-Built, Sheets 1-10, CLA
Engineers, Inc.
8. Cook Road Drainage and Water Main Improvements, Montville,
Connecticut, AS-Built Revised October 2000, CLA Engineers, Inc.
9. Rt 32 Water Main Extension, Webb Drive to Podargel Lane,
As-Built, Dated 5/28/97, CLA Engineers, Inc.
10. Thames Basin Regional Water Interconnection Project, Montville,
Connecticut, As-Built Drawings of the Thames River Line, September
2007, 13 sheets
11. Thames Basin Regional Water Interconnection Project, Montville,
Connecticut, Site Work for Booster Pumping Station and Appurtenant
Work, Site Plan, 10/1/04, Sheet 1 of 4
12. Southeastern Connecticut Water Authority, Water Main Extension,
Interconnection of Hillcrest with Town of Montville System, Revised
through 12/05/2007, Sheet CU-101
13. Town of Montville, Connecticut, Palmetown Water Project, Maple
Avenue Site Plan, 9/05, Sheet G-5
14. Thames Basin Regional Water Interconnection Project, Montville,
Connecticut, Construction of Watermains and Appurtenant Work at
Dock Road, Phase-2 Dock Road & New England Central Railroad
Crossing, Revised through 11/09/07, Sheet 2 of 5



LEGEND

- x WATER GATE
- o BUTTERFLY VALVE
- ARV AIR RELEASE VALVE

ALL VALVES ARE OPEN LEFT UNLESS
WHERE AN "X" IS SHOWN. WHERE ALL
BYPASS VALVES ARE NORMALLY CLOSED
THEY ARE ACCOMPANIES BY "NC".

GRAPHIC SCALE
0 300 600 900 1200
SCALE: 1"=600'

Nathan L. Jacobson & Associates, Inc.
86 Main Street, P.O. Box 337
Chester, Connecticut 06412-0337
Tel: (860) 526-9591 Fax: (860) 526-5416
www.nljac.com
Consulting Civil and Environmental Engineers Since 1972

Water Supply System
Montville Water Pollution
Control Authority
Montville, Connecticut